
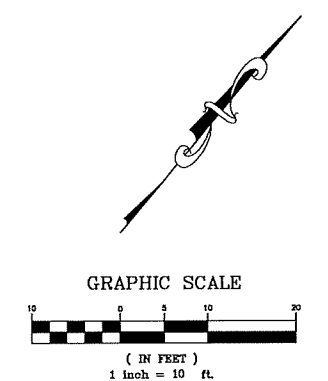


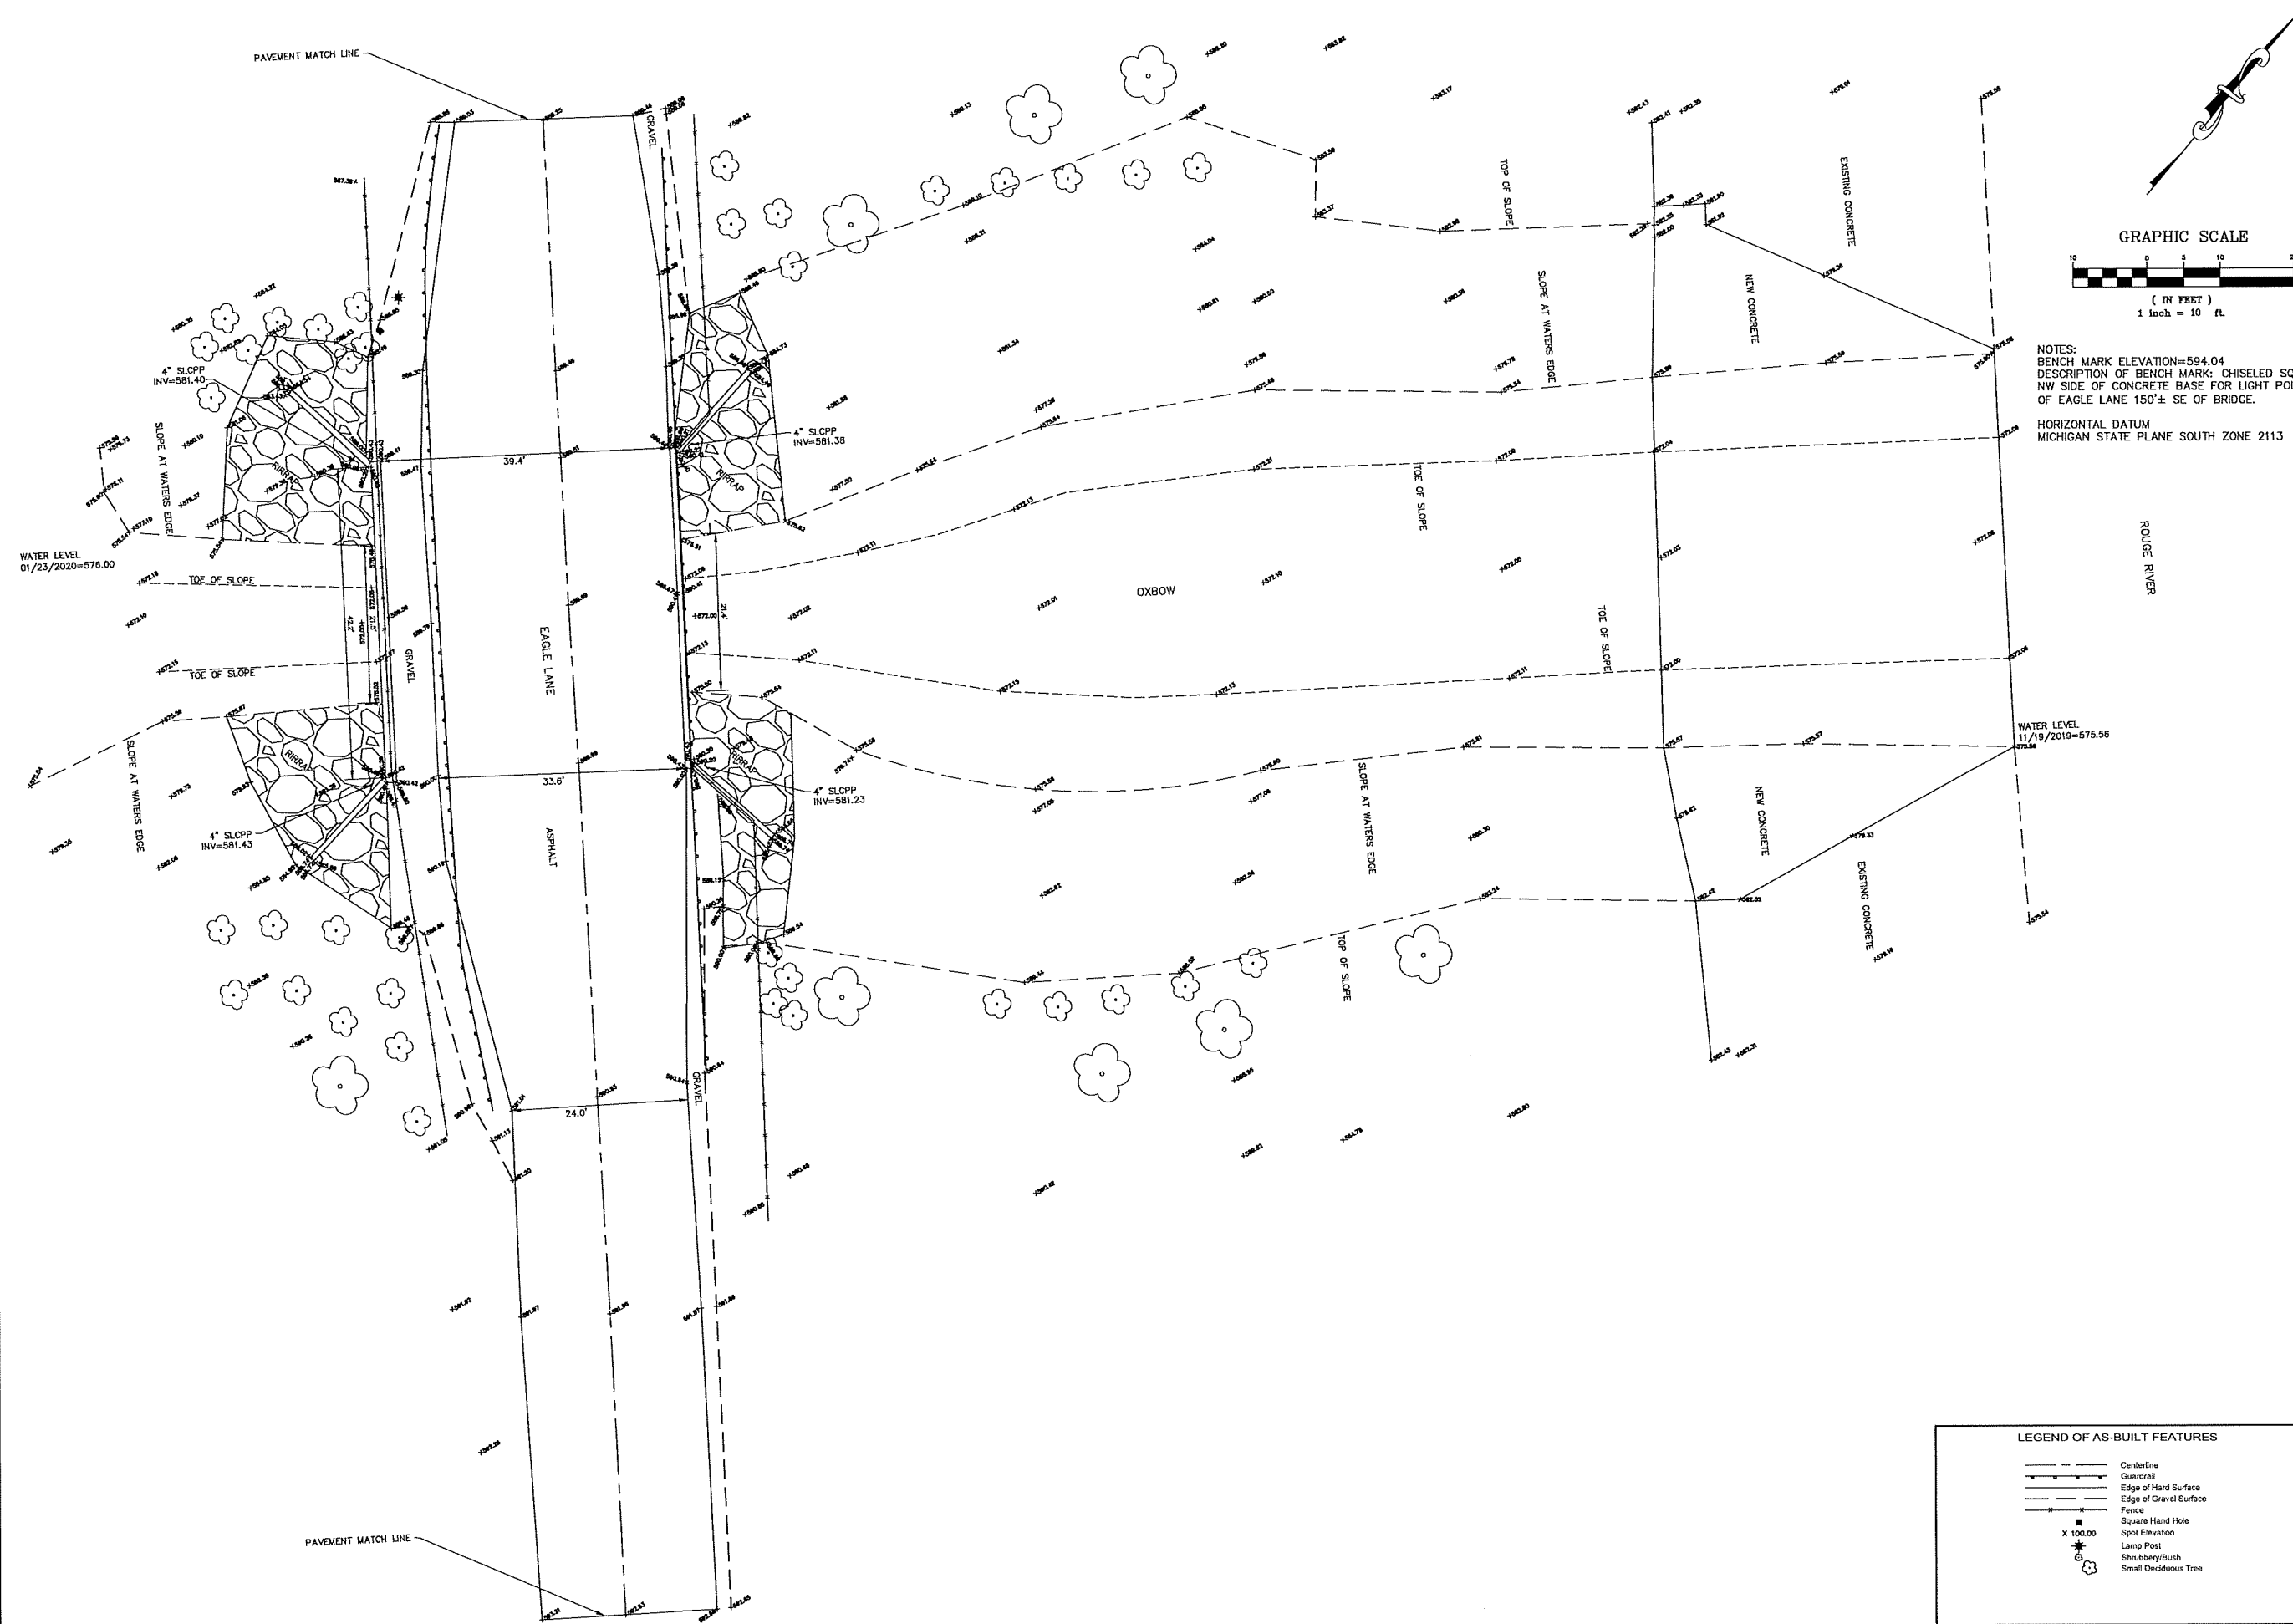

NOTES:
BENCH MARK ELEVATION=594.04
DESCRIPTION OF BENCH MARK: CHISELED SQUARE ATOP
NW SIDE OF CONCRETE BASE FOR LIGHT POLE ON WEST SIDE
OF EAGLE LANE 150'± SE OF BRIDGE.
HORIZONTAL DATUM
MICHIGAN STATE PLANE SOUTH ZONE 2113

LEGEND OF AS-BUILT FEATURES	
	Centerline
	Guardrail
	Edge of Hard Surface
	Edge of Gravel Surface
	Fence
	Square Hand Hole
	Spot Elevation
	Lamp Post
	Shrubbery/Bush
	Small Deciduous Tree



CIVIL ENGINEERS & LAND SURVEYORS
519 HURON AVE. PORT HURON, MI 48060
TEL: 810-984-5556 FAX: 810-984-8760
Web Page: www.bmlinc.com Email: mail@bmlinc.com

FOR: EC KORNEFFEL

ROUGE OXBOW RESTORATION
PHASE III
AS-BUILTS

NO.	REVISIONS	DATE

SCALE: 1" = 10'
DATE: 02/12/2020
SURVEYED: AB
DRAWN: CMF
CHKD: RJA
JOB NO. 1808-16
SHT. 1 OF 2

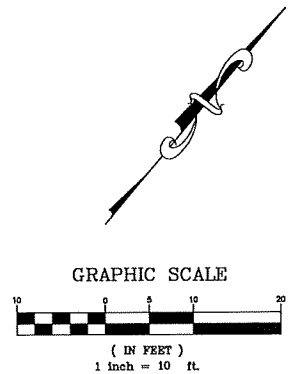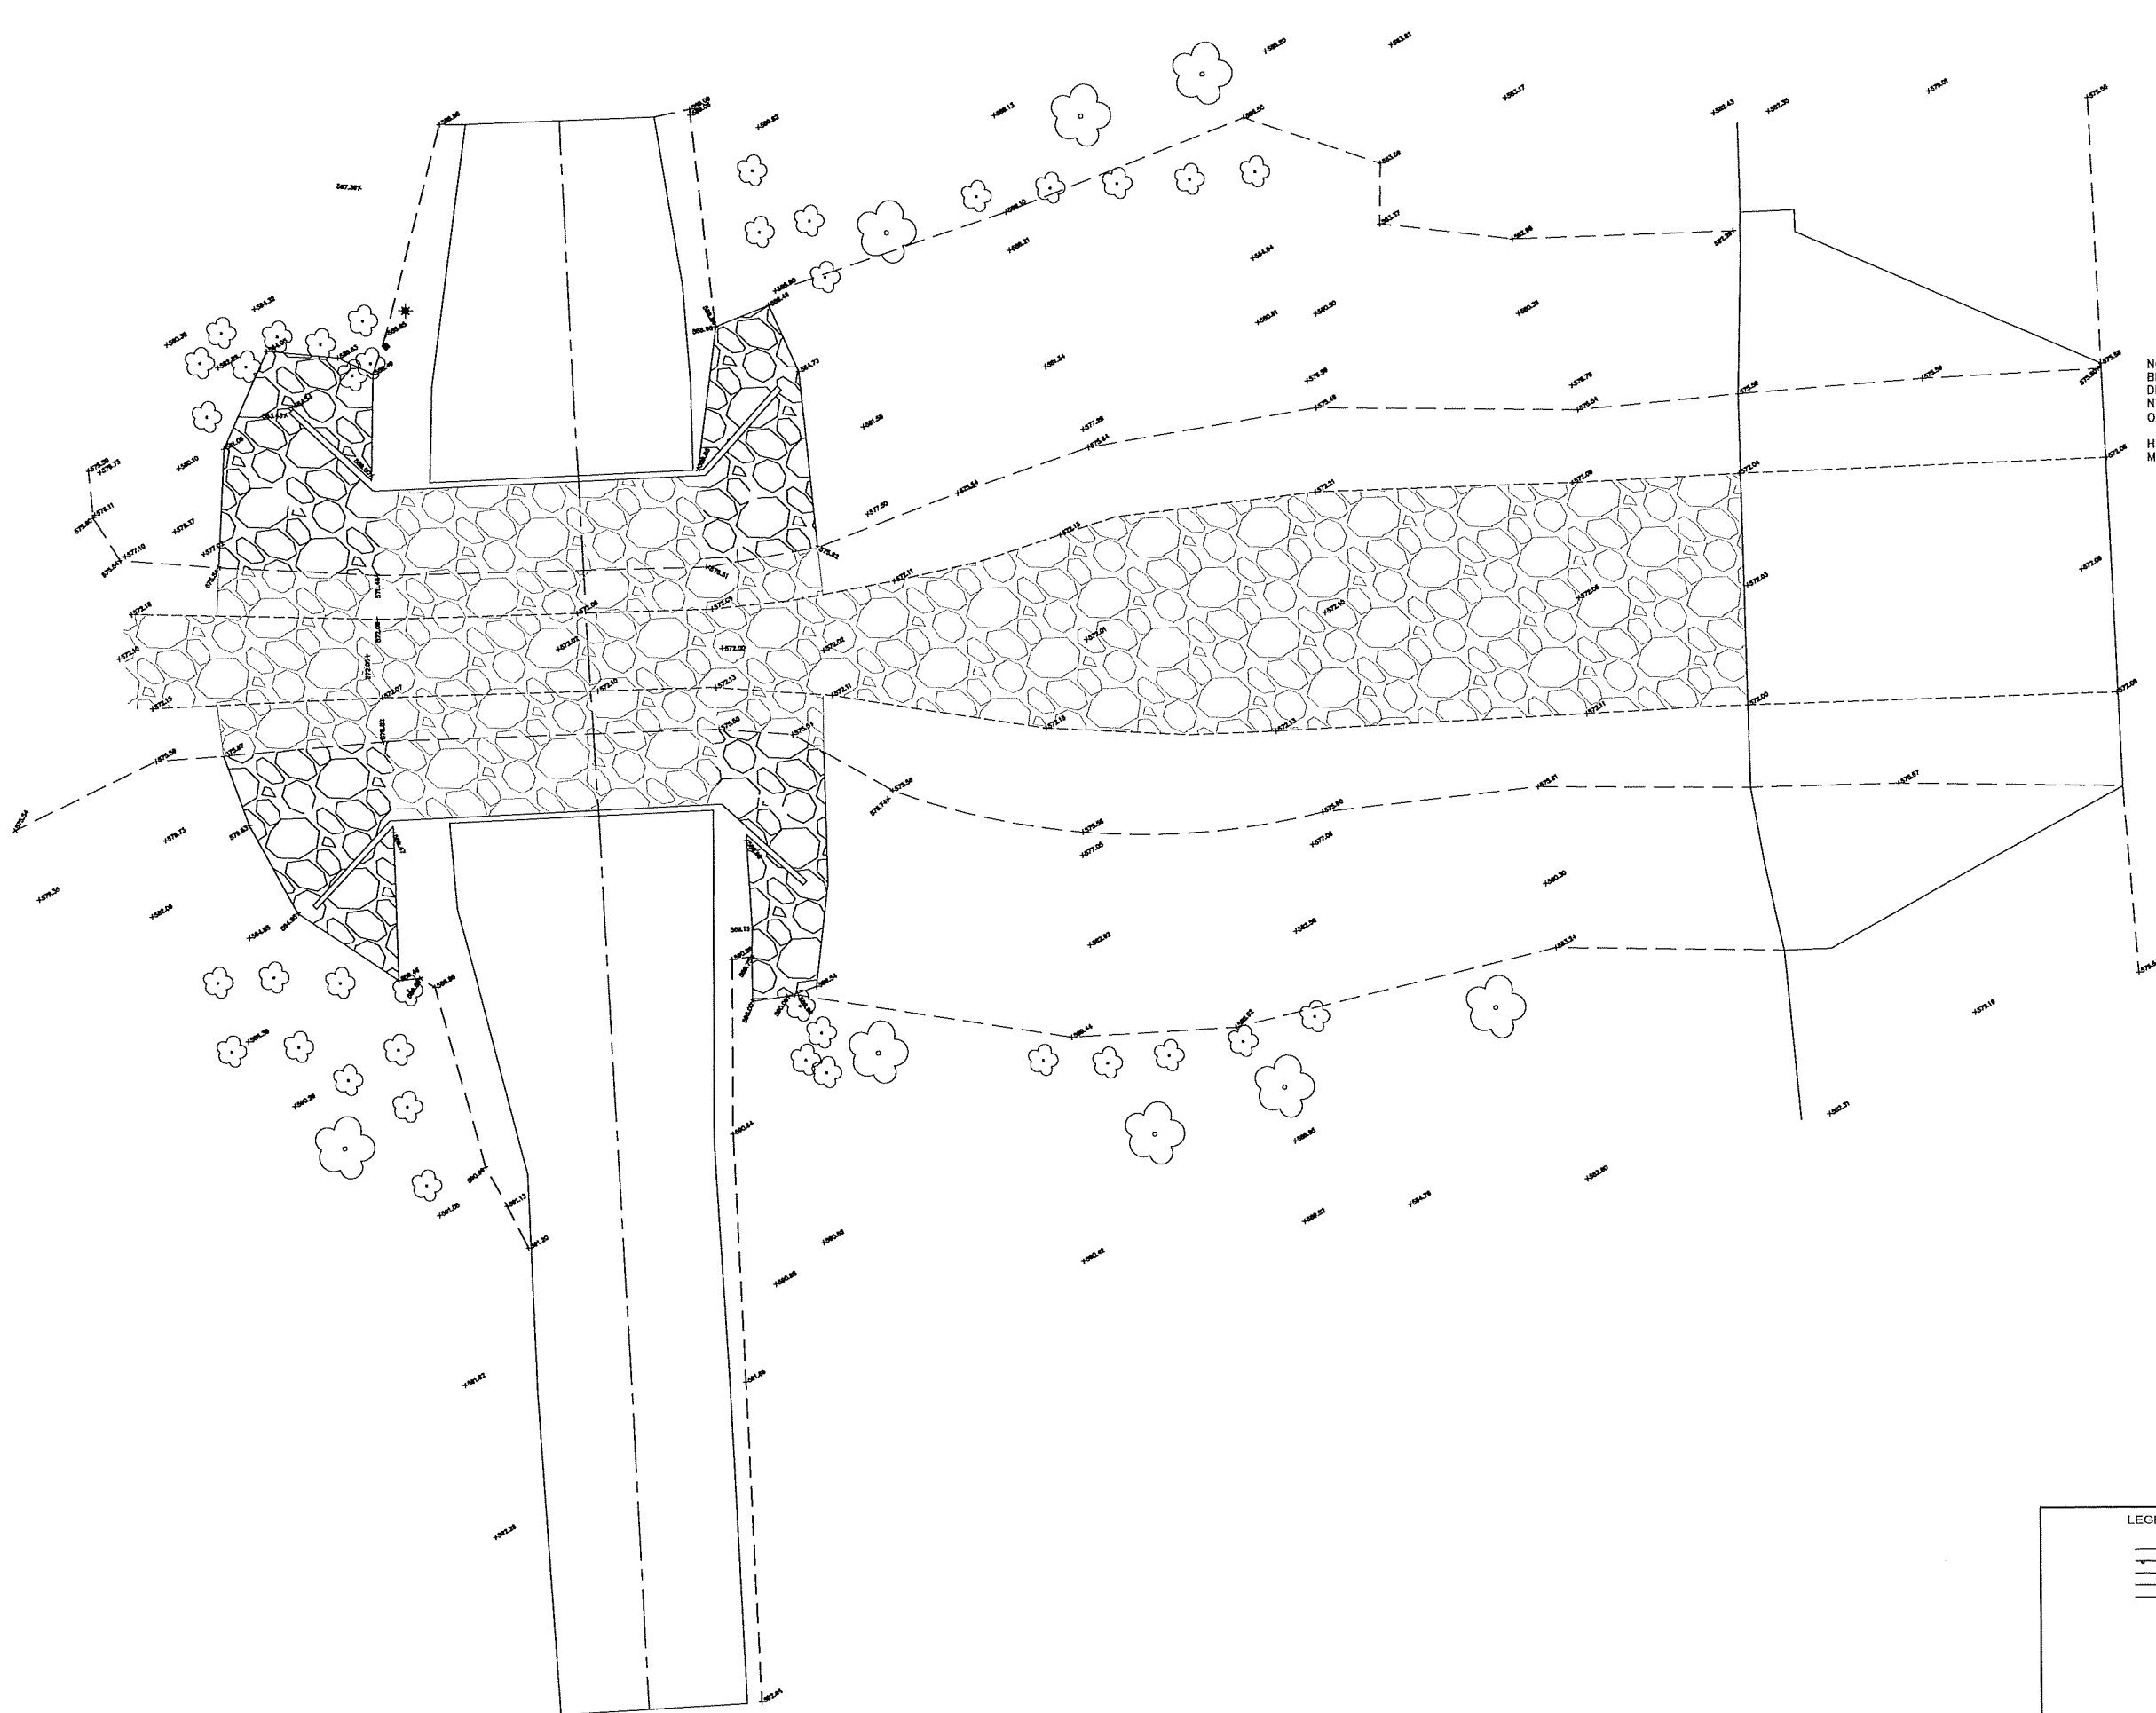

NOTES:
 BENCH MARK ELEVATION=594.04
 DESCRIPTION OF BENCH MARK: CHISELED SQUARE ATOP
 NW SIDE OF CONCRETE BASE FOR LIGHT POLE ON WEST SIDE
 OF EAGLE LANE 150'± SE OF BRIDGE.

HORIZONTAL DATUM
 MICHIGAN STATE PLANE SOUTH ZONE 2113

LEGEND OF AS-BUILT FEATURES	
—+—+—+—	Centerline
—x—x—x—x—	Guardrail
—+—+—+—+—	Edge of Hard Surface
—x—x—x—x—	Edge of Gravel Surface
—x—x—x—x—	Fence
■	Square Hand Hole
x 100.00	Spot Elevation
*	Lamp Post
☼	Shrubbery/Bush
☼	Small Deciduous Tree

CIVIL ENGINEERS & LAND SURVEYORS
 519 HURON AVE. PORT HURON, MI 48060
 TEL: 810-984-5596 FAX: 810-984-8760
 Web Page: www.bmjinc.com Email: mail@bmjinc.com

FOR: EC KORNEFFEL

ROUGE OXBOW RESTORATION
 PHASE III
 AS-BUILTS

NO.	REVISIONS	DATE
1		

SCALE: 1" = 10'

DATE: 02/12/2020


SURVEYED: AB

DRAWN: CMF

CHKD: RJA


JOB NO. 1808-16

SHT. 2 OF 2

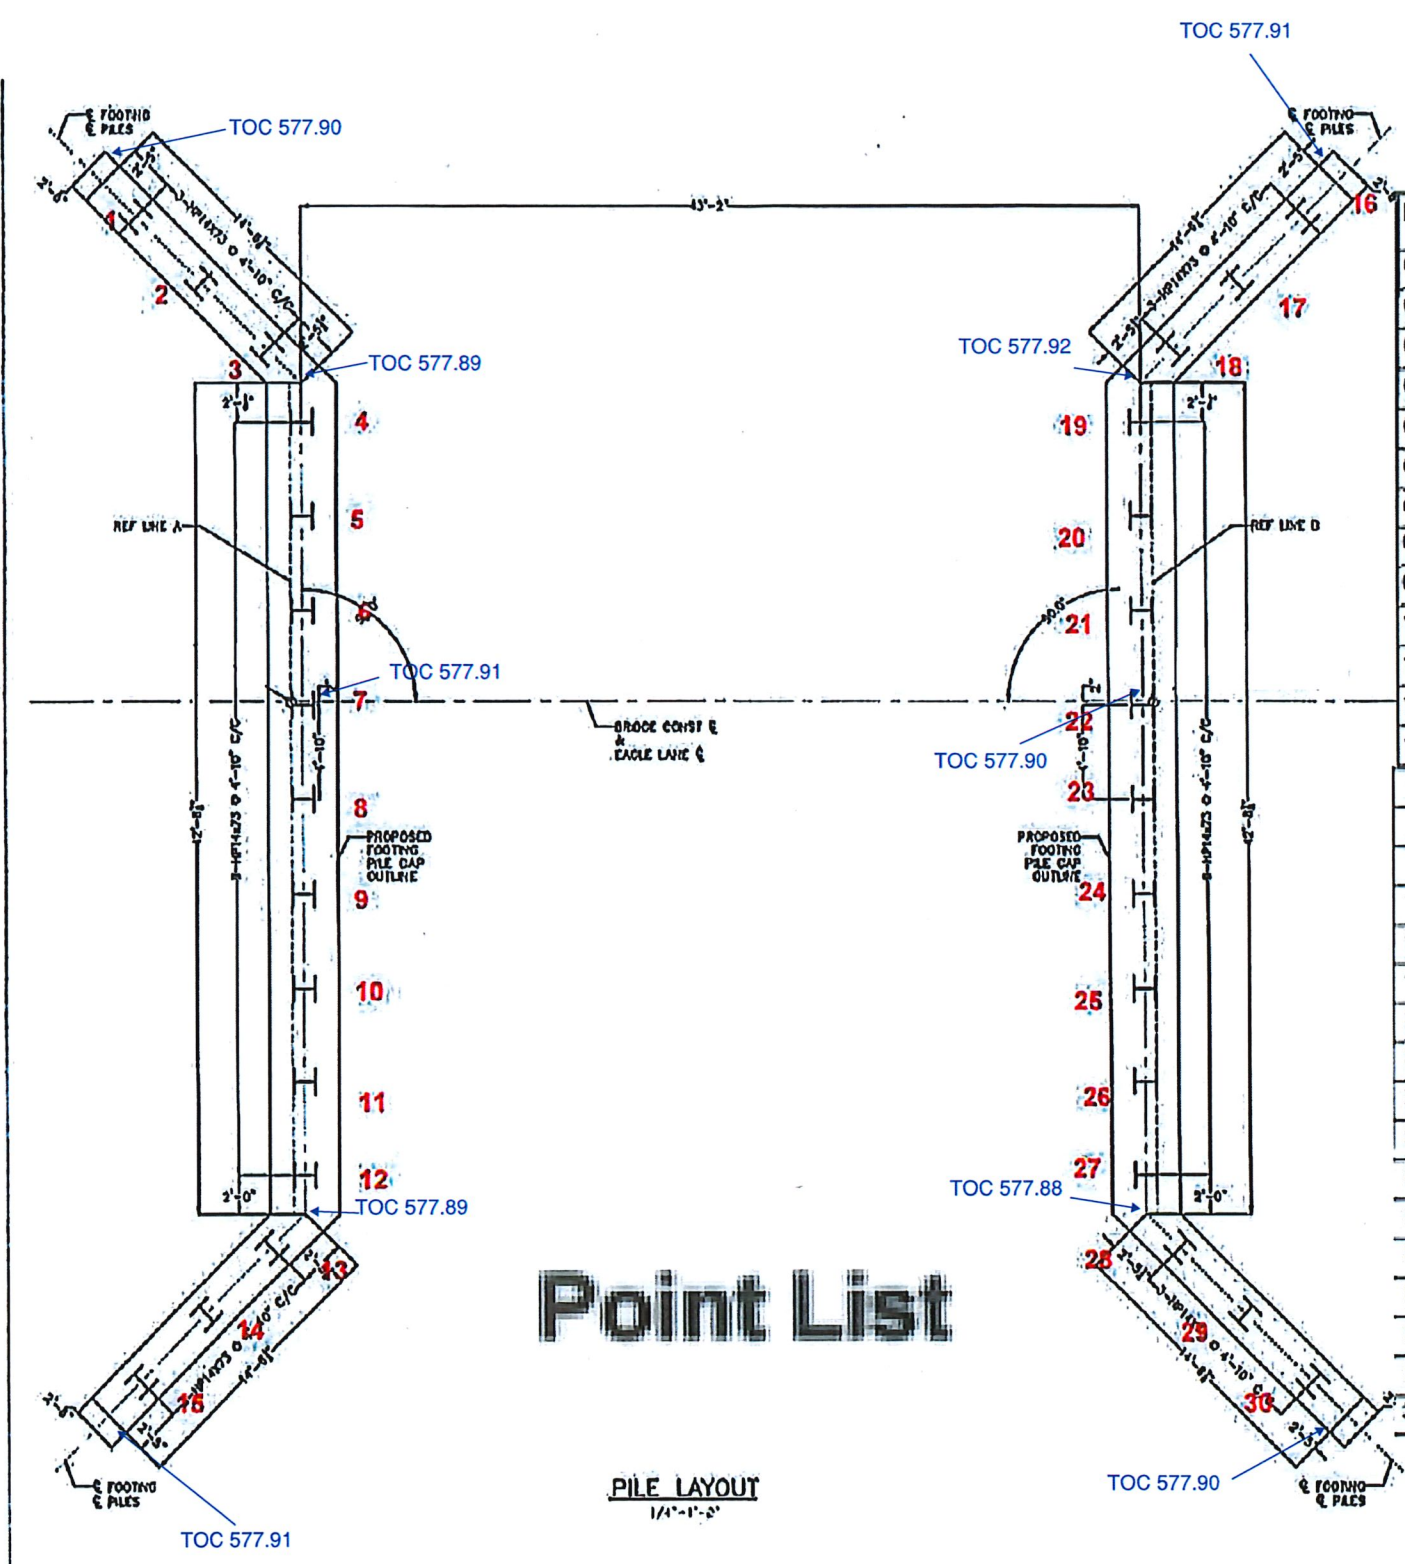

Point List

 PILE LAYOUT
1/4" = 1'-0"



Point List

ID	Northing (International foot)	Easting (International foot)	Elevation (International foot)	Feature Code
01	295482.91	13432941.77	576.62	CL PILE
02	295487.59	13432941.97	576.60	8073
03	295492.49	13432942.10	578.83	8074
04	295496.17	13432943.07	576.02	8075
05	295499.54	13432947.33	576.61	8076
06	295502.78	13432950.77	576.83	8077
07	295505.98	13432954.36	576.82	8078
08	295509.21	13432957.89	570.03	8079
09	295512.53	13432961.48	576.63	8080
10	295515.80	13432965.13	576.61	8081
11	295519.00	13432968.58	576.61	8082
12	295522.32	13432972.21	576.62	8083
13	295523.52	13432976.20	576.58	8084
14	295523.42	13432981.01	576.61	8085
15	295523.21	13432985.83	576.57	8086
16	295507.00	13432944.98	576.62	8087
17	295502.82	13432944.82	570.00	8088
18	295567.00	13432944.03	570.03	8089
19	295554.04	13432942.87	576.83	8090
20	295550.98	13432939.61	576.62	8091
21	295547.72	13432935.97	576.82	8092
22	295544.35	13432932.47	576.81	8093
23	295541.17	13432928.76	576.82	8094
24	295537.88	13432925.34	570.59	8095
25	295534.63	13432921.77	576.60	8096
26	295531.26	13432918.10	576.62	8097
27	295528.16	13432914.82	576.61	8098
28	295526.80	13432910.83	576.62	8099
29	295526.85	13432905.84	576.00	8100
30	295527.27	13432901.02	576.61	8101

Environmental Consulting & Technology, Inc.
2700 Central Expressway, Suite 200
Folsom, CA 95630
Phone: 916.451.1100
Fax: 916.451.1101

Somat Engineering

Applied Science, Inc.
Geotechnical Engineering

Alliance of Rouge Communities
OURS TO PROTECT
Working together to protect the river

OXBOW RESTORATION PROJECT - PHASE III

DEARBORN, WAYNE COUNTY, MICHIGAN

CITY OF DEARBORN
MICHIGAN

the Henry Ford

DESIGNED BY	ECT
DRAWN BY	ECT
CHECKED BY	ECT
APPROVED BY	ECT
DATE	08/11/11

PILE LAYOUT

AS BUILT

NORTH
 NORTH
S-4

J. HUBBARD LIND
 BEFORE YOU DIG
 CALL MISS DIG
 1-800-482-7171